


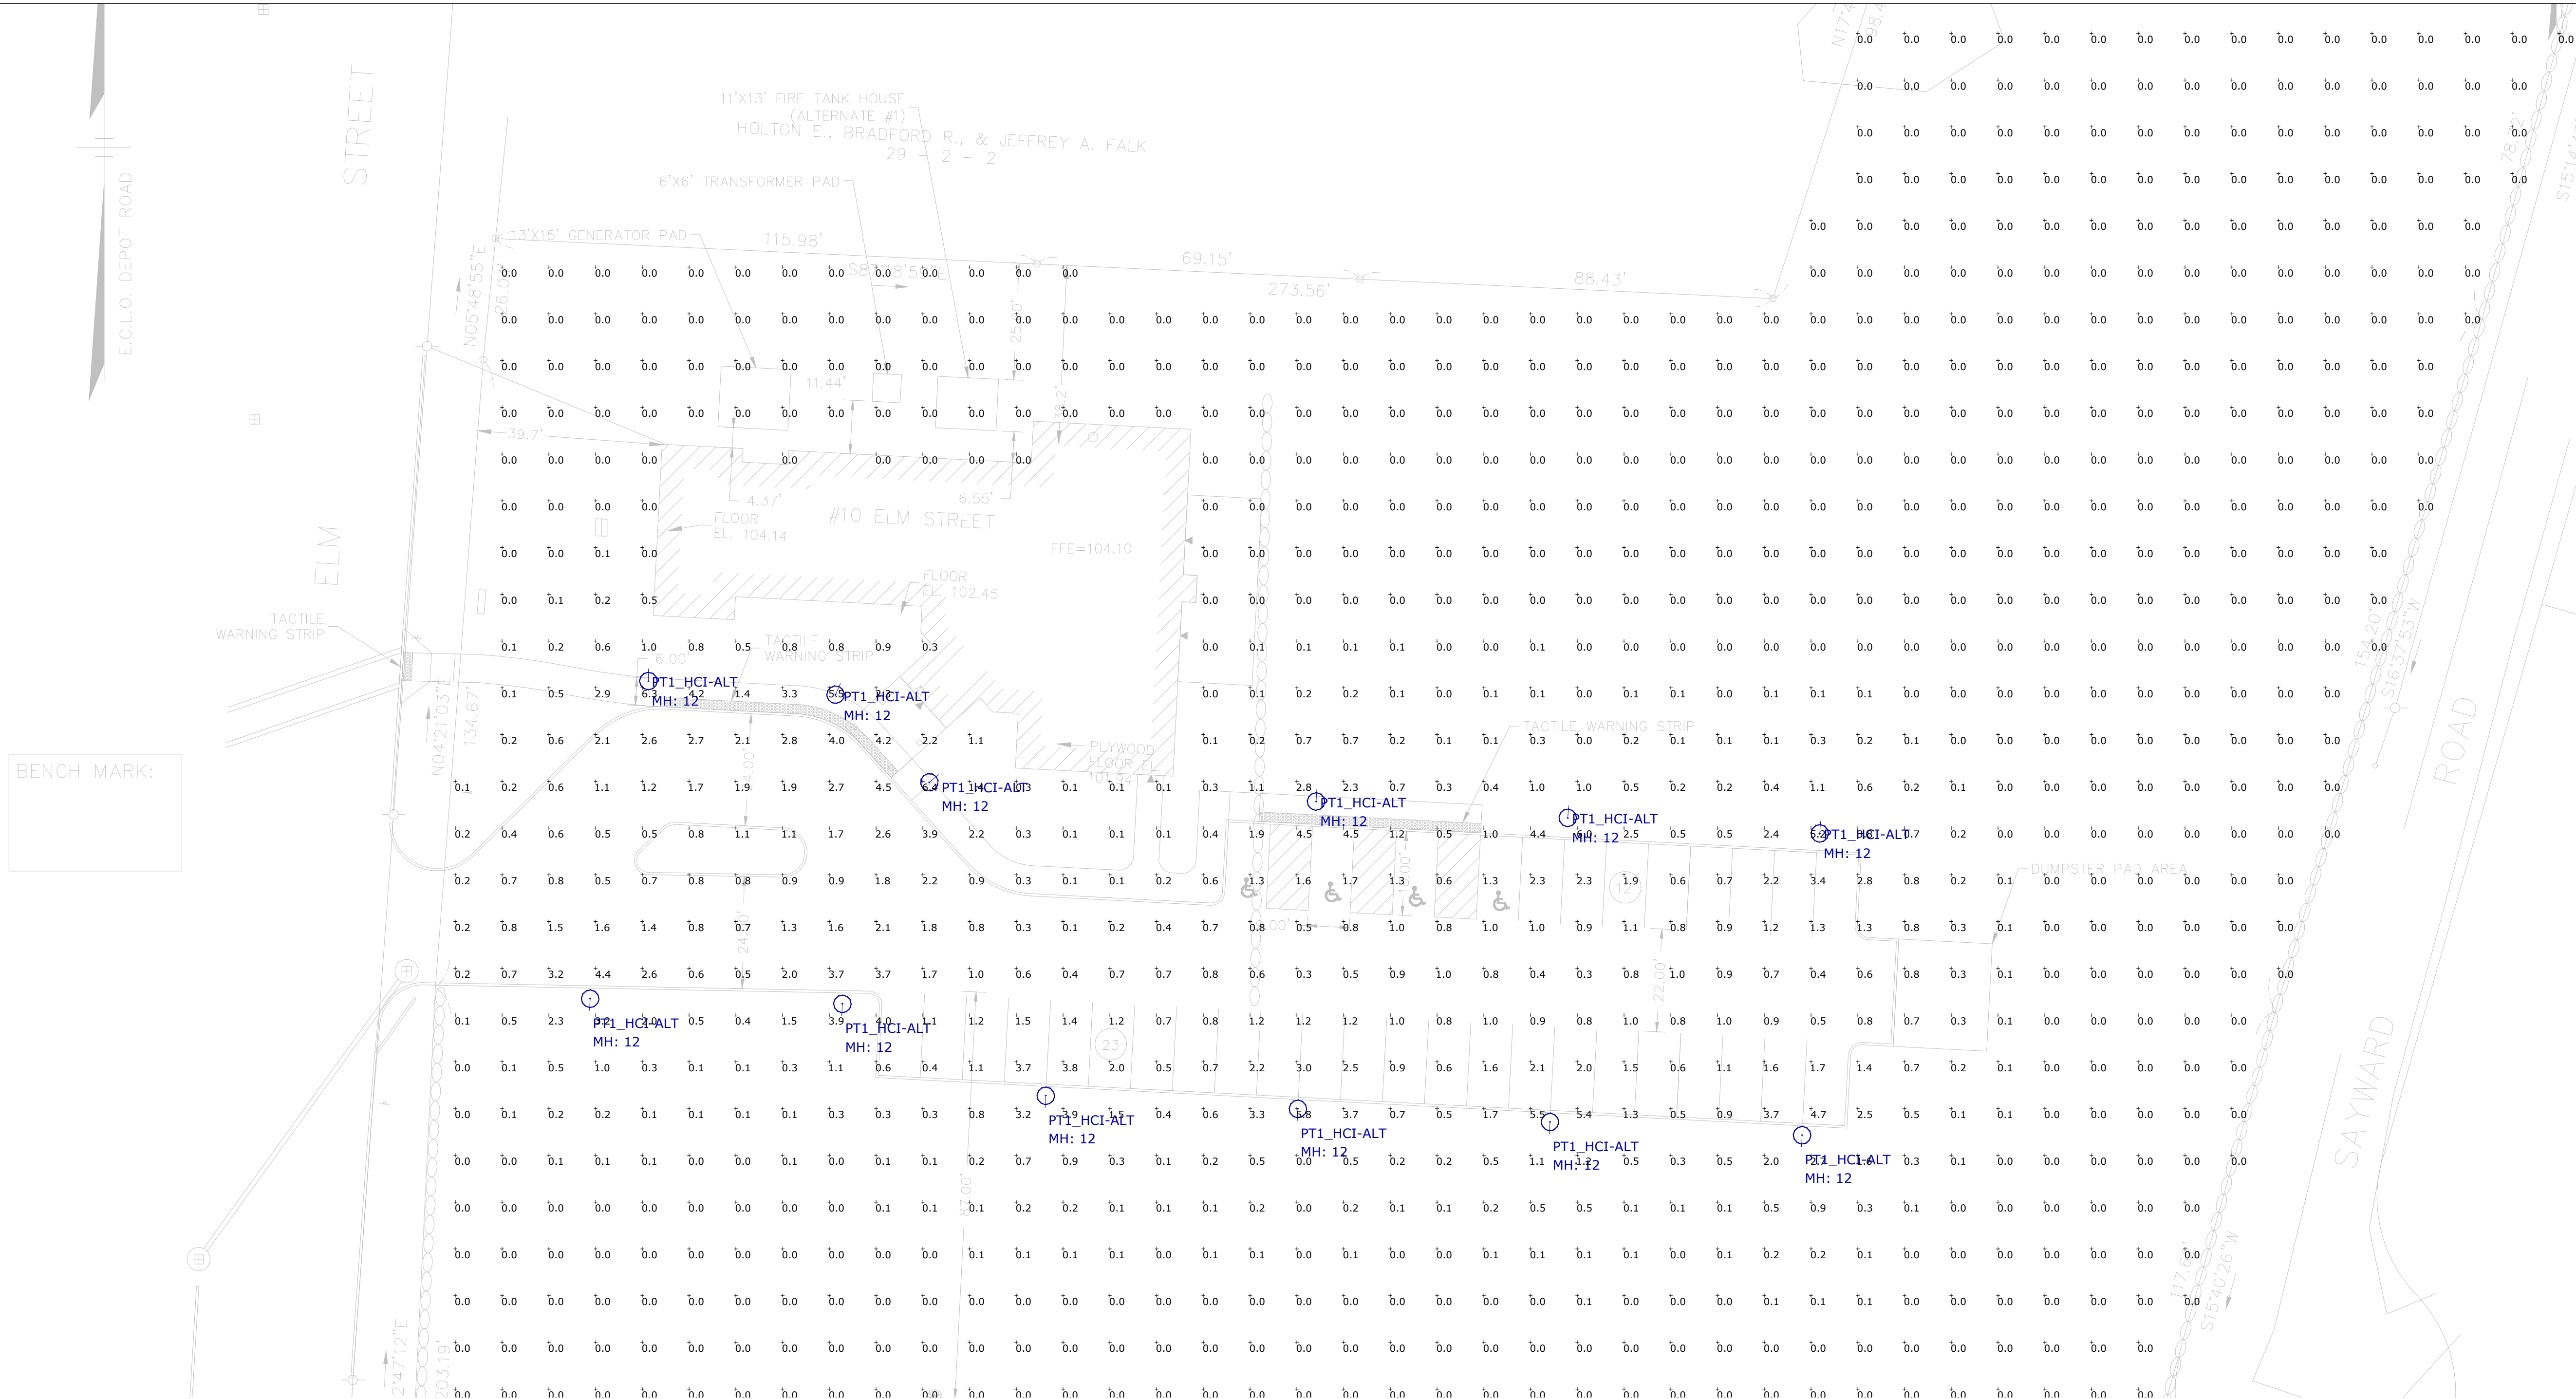

Luminaire Schedule

Symbol	Label	Qty	Description	LLF	Lum. Watts	Lum. Lumens
	PT1_HCI-	12	HCI Lighting # F180-L-FPC-55W-3K-120-277V-IV-DIM	0.700	55	5262

Calculation Summary

Label	CalcType	Units	Avg	Max	Min	Avg/Min	Max/Min
Site Points	Illuminance	Fc	0.30	6.4	0.0	N.A.	N.A.

NOTES:

- A. A LIGHT LOSS FACTOR OF 0.900 HAS BEEN APPLIED TO FIXTURES UNLESS OTHERWISE NOTED. REFER TO LUMINAIRE SCHEDULE FOR LIGHT LOSS FACTOR AND LUMEN INFORMATION.
- B. SEE "MH" ON LIGHTING FIXTURE TAG LOCATED ON PLAN FOR MOUNTING HEIGHT INFORMATION.
- C. CALCULATION POINTS ARE TAKEN AT GRADE.
- D. CALCULATION RESULTS ARE BASED ON IES STANDARDS UNLESS OTHERWISE REQUESTED.

DATE:	September 15, 2020	REVISIONS	DESCRIPTION	DATE
PROJECT NUMBER:	20150	1		
DRAWN BY:	AD	2		
CHECKED BY:	HD	3		
APPROVED BY:	HD	4		
SCALE:	1"=20'-0"	5		
		6		
		7		