


MECHANICAL FIRST FLOOR DUCTWORK PLAN
SCALE: 1/8"=1'-0"

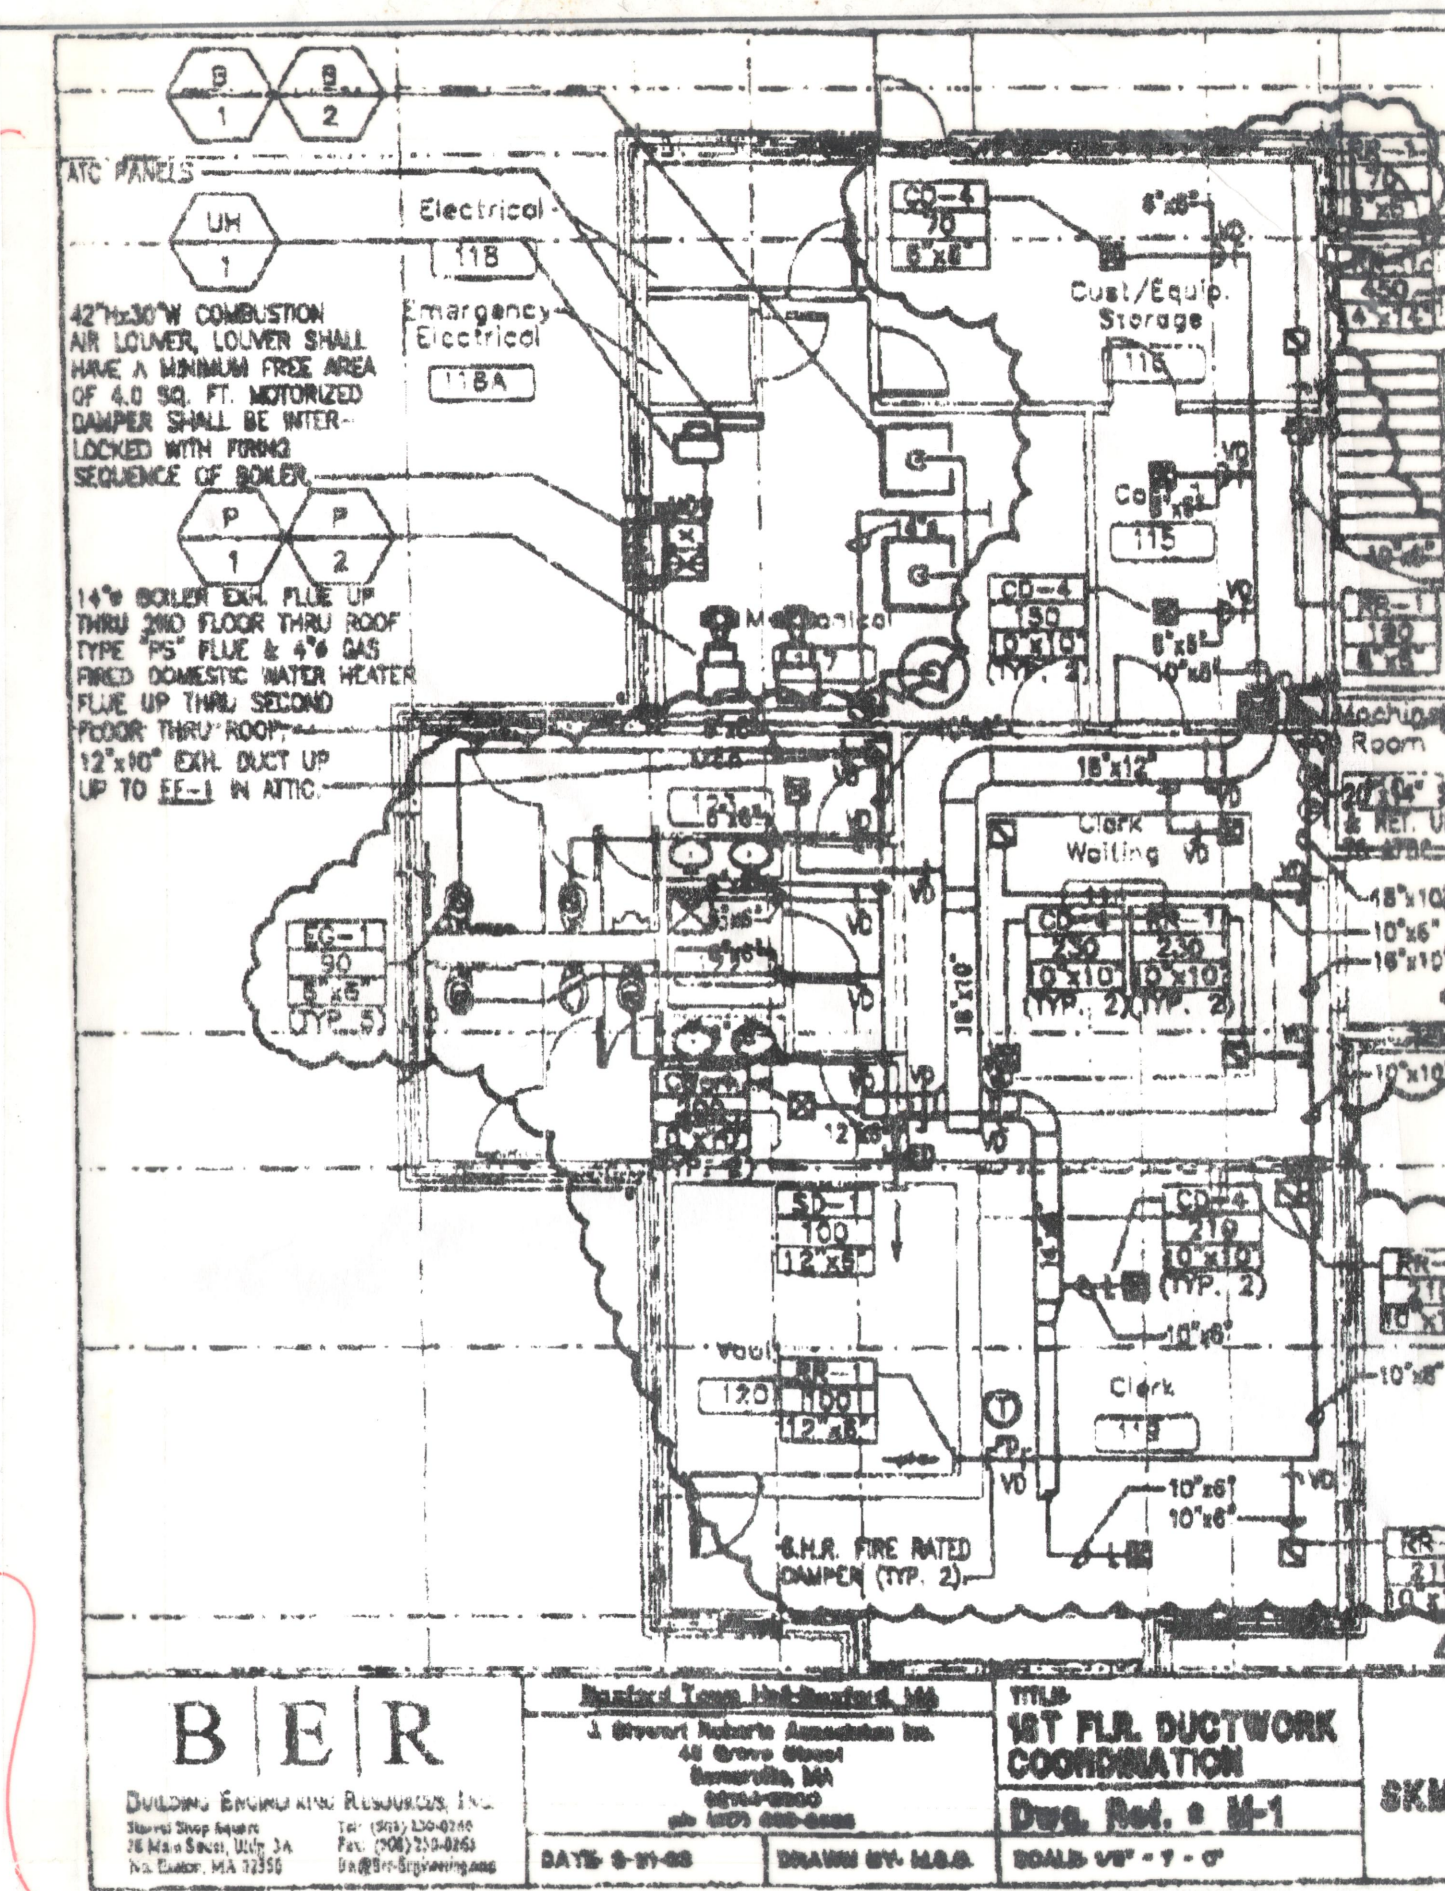

J. STEWART
ROBERTS
ASSOCIATES INC.
ARCHITECTS

48 GROVE STREET
SOMERVILLE, MA
02144-2500



BER
BUILDING ENGINEERING RESOURCES, INC.
28 Main Street, Bldg. 3A
Somerville, MA 02144
Tel: (609) 230-0260
Fax: (609) 230-0265
Ber@ber-engineering.com

Revisions:

BOXFORD TOWN HALL
Boxford, Massachusetts

Sheet Title:
Mechanical
First Floor
Ductwork
Plan
Date: 01 Mar 02 Drawn By: JMR
Scale: 1/8"=1'-0" Project No:

M1.0

