

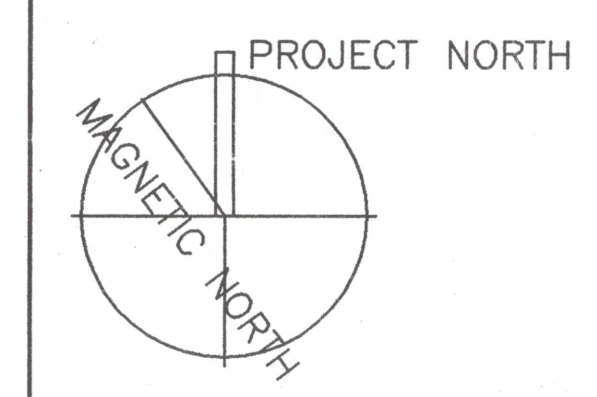


MECHANICAL SECOND FLOOR DUCTWORK PLAN
SCALE: 1/8"=1'-0"

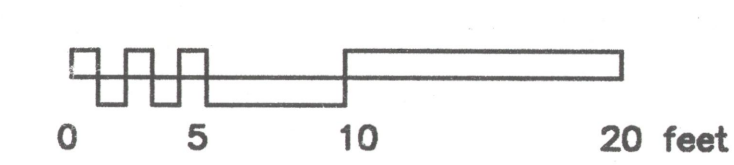

**J. STEWART
ROBERTS
ASSOCIATES INC.**
ARCHITECTS

**48 GROVE STREET
SOMERVILLE, MA
02144-2500**

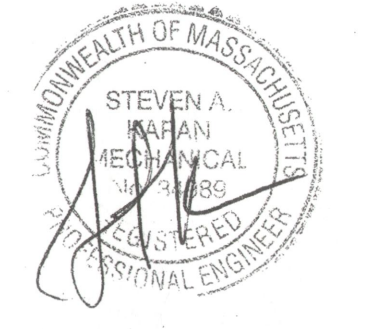

BER
BUILDING ENGINEERING RESOURCES, INC.
28 Main Street, Bldg. 3A
No. Easton, MA 02359
Tel: (508) 230-0300
Fax: (508) 230-0265
ber@stewartroberts.com

Revisions:

BOXFORD TOWN HALL
Boxford, Massachusetts

Sheet Title:
**Mechanical
Second Floor
Ductwork
Plan**

Date: 01 Mar 02 Drawn By: JMR
Scale: 1/8"=1'-0" Project No.:

M3.0

ADD#1