



MECHANICAL SECOND FLOOR PIPING PLAN  
 SCALE: 1/8"=1'-0"

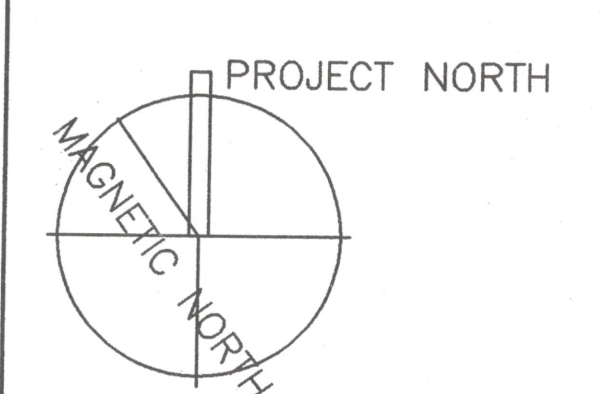

**J. STEWART  
 ROBERTS  
 ASSOCIATES INC.**  
 ARCHITECTS

48 GROVE STREET  
 SOMERVILLE, MA  
 02144-2500

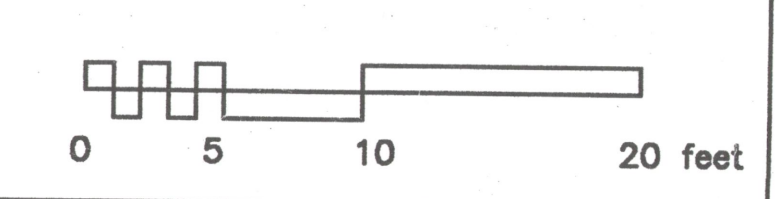

**B | E | R**  
 BUILDING ENGINEERING RESOURCES, INC.  
 Steve Ship Square  
 28 Main Street, Bldg. 3A  
 No. Yarmouth, MA 02196  
 Tel: (978) 230-0200  
 Fax: (978) 230-0205  
 Ber@Ber-Engineering.com

Revisions:


BOXFORD TOWN HALL  
 Boxford, Massachusetts

Sheet Title:  
 Mechanical  
 Second Floor  
 Piping Plan

Date: 01 Mar 02 Drawn By: JMR  
 Scale: 1/8"=1'-0" Project No.:

M4.0