

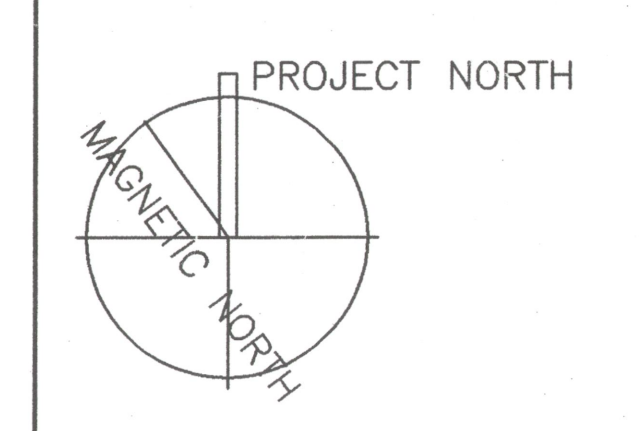


MECHANICAL ATTIC PIPING PLAN  
SCALE: 1/8"=1'-0"

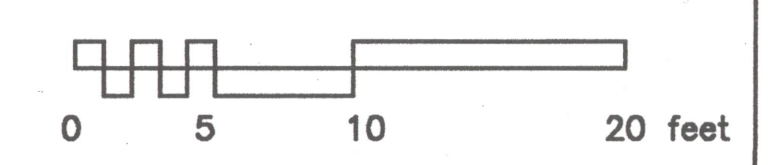

**J. STEWART  
ROBERTS  
ASSOCIATES INC.**  
**ARCHITECTS**

**48 GROVE STREET  
SOMERVILLE, MA  
02144-2500**

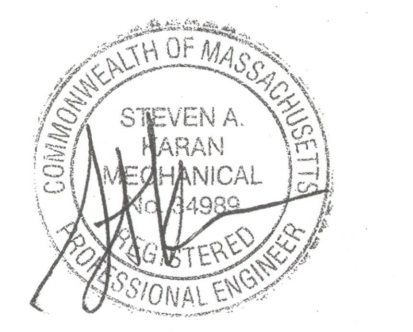

**B E R**  
BUILDING ENGINEERING RESOURCES, INC.  
Steven Roberts  
28 Main Street, 3rd Fl., Somerville, MA 02144  
Tel: (617) 231-6200  
Fax: (617) 231-6205  
Ber@ber-engineering.com

Revisions:


BOXFORD TOWN HALL  
Boxford, Massachusetts

Sheet Title:  
**Mechanical  
Attic  
Piping  
Plan**  
Date: 01 Mar 02 Drawn By: JHR  
Scale: 1/8"=1'-0" Project No.:

M6.0